



SCHEDULE					
DOORS					
NO.	SIZE	TYPE	FINISH	REMARKS	QTY
1	3' x 6' x 1 1/2"	WOOD-SOLID	1-LIGHT	EMERALD-VENEER	1
2	3' x 6' x 1 1/2"	2-PANEL ALUMINUM	STORM DOOR	EMERALD-VENEER	1
3	2' x 6' x 1 1/2"	WOOD-FLUSH HOLLOW-CORE	"	"	3
4	2' x 6' x 1 1/2"	"	"	"	2
5	2' x 6' x 1 1/2"	"	"	"	3
6	2' x 6' x 1 1/2"	"	"	"	2
7	4' x 6' x 1 1/2"	"	"	"	3
8	4' x 6' x 1 1/2"	4-PANEL FULL-LENGTH	FR. GLIDING	EMERALD-VENEER / FR. GLIDING	1
9	2' x 6' x 1 1/2"	2-PANEL FULL-LENGTH GLASS	3/8" GLASS INSULATED	"	1
WINDOWS					
NO.	SIZE	TYPE	FINISH	REMARKS	QTY
A	3' x 4'	WOOD FRAME	SLIP 1/2"	3/8" GLASS INSULATED	5
B	3' x 3'	WOOD FRAME	SLIP 1/2"	"	2
C	3' x 2'	WOOD FRAME	SLIP 1/2"	"	2
KEY	SIZE	TYPE	REMARKS	QTY	

FLOOR PLAN SCALE: 1/4" = 1'-0"


COOPERATIVE EXTENSION WORK IN
 AGRICULTURE AND HOME ECONOMICS
 STATE OF SOUTH CAROLINA
 CLEMSON UNIVERSITY

ENERGY EFFICIENT HOUSE

EX. 2014 SHEET 3 OF 7

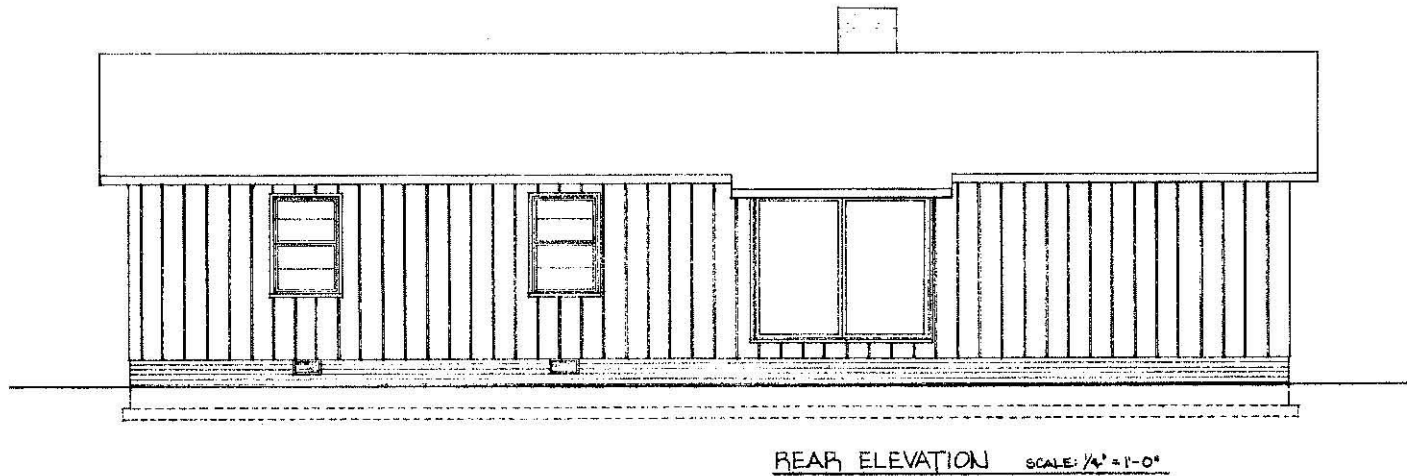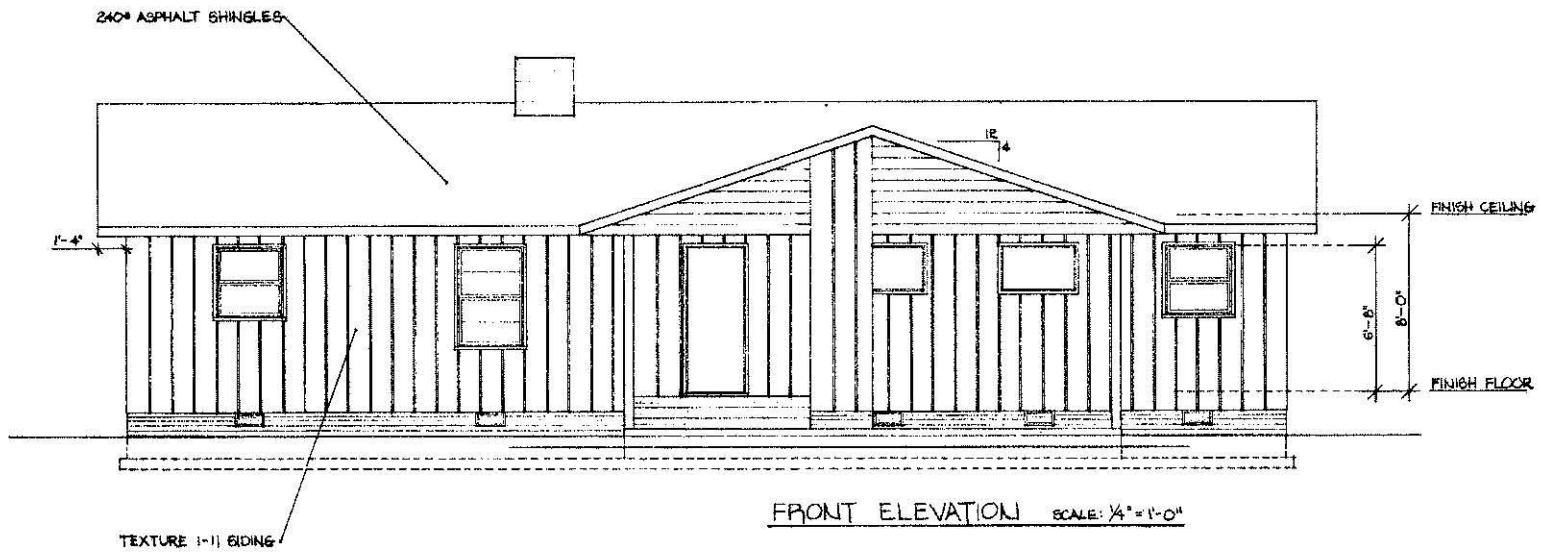


COOPERATIVE EXTENSION WORK IN AGRICULTURE AND HOME ECONOMICS		
STATE OF SOUTH CAROLINA CLEMSON UNIVERSITY		
AND UNITED STATES DEPARTMENT OF AGRICULTURE, COOPERATING		
ENERGY EFFICIENT HOUSE		
SC '80	EX. 8014	SHEET 3 OF 7

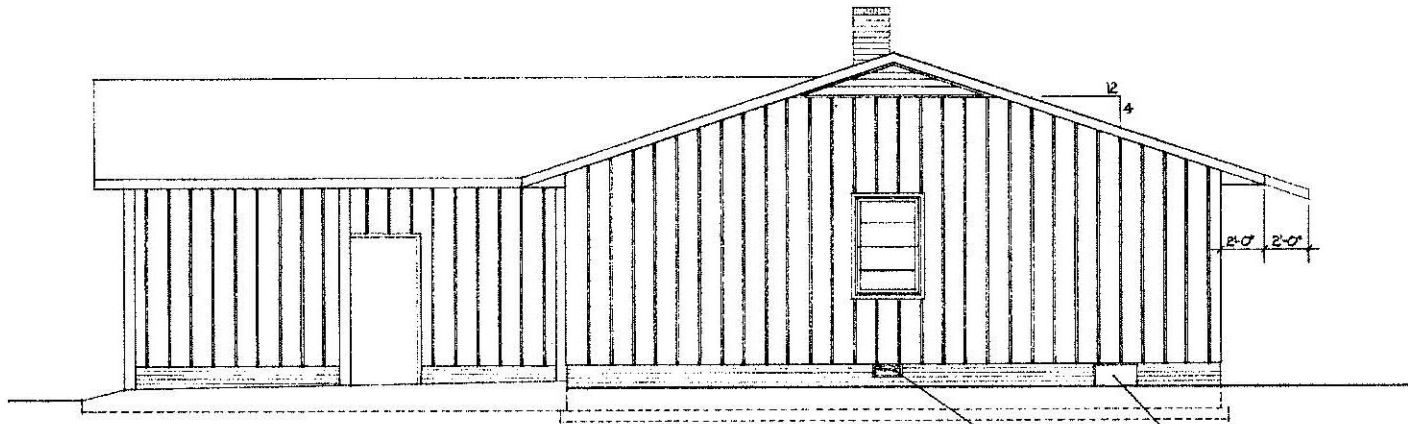

RIGHT SIDE ELEVATION SCALE: 1/4" = 1'-0"



6" x 6" FOUNDATION VENT ACCESS DOOR

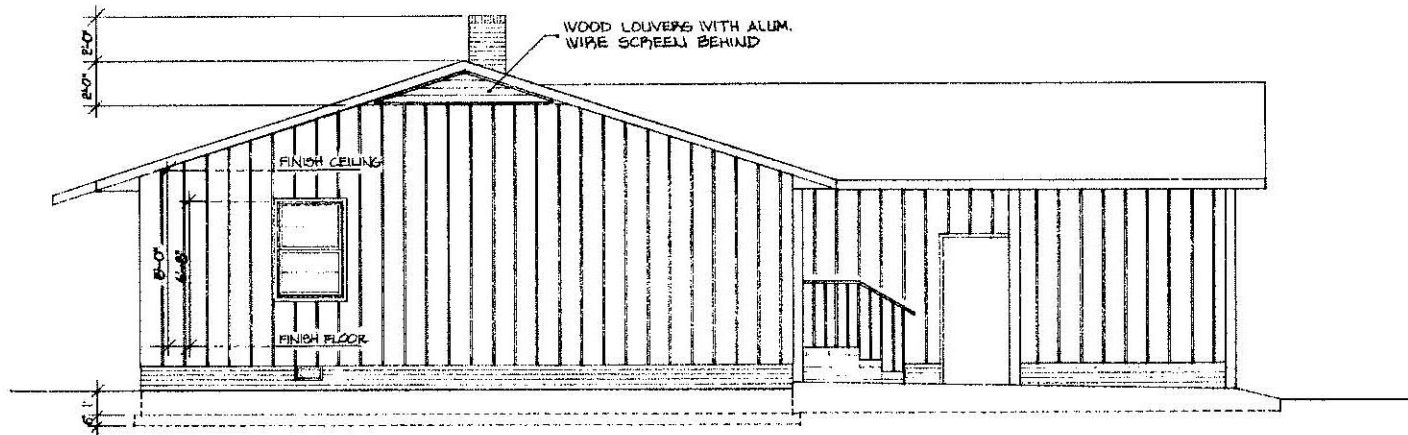


LEFT SIDE ELEVATION SCALE: 1/4" = 1'-0"

COOPERATIVE EXTENSION WORK IN AGRICULTURE AND HOME ECONOMICS		
STATE OF SOUTH CAROLINA		
CLEMSON UNIVERSITY		
UNITED STATES DEPARTMENT OF AGRICULTURE		
ENERGY EFFICIENT HOUSE		
SC 100	EX. 8014	SHEET 4 OF 7


240° ASPHALT SHINGLES
 15# FELT
 1/2" SHEATHING
 TRUSS 2' O.C.
 6" INSULATION (BATT)
 2x6 HEADERS
 2x4 NAILER

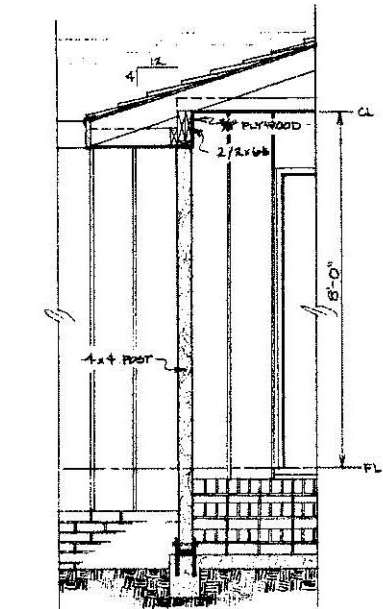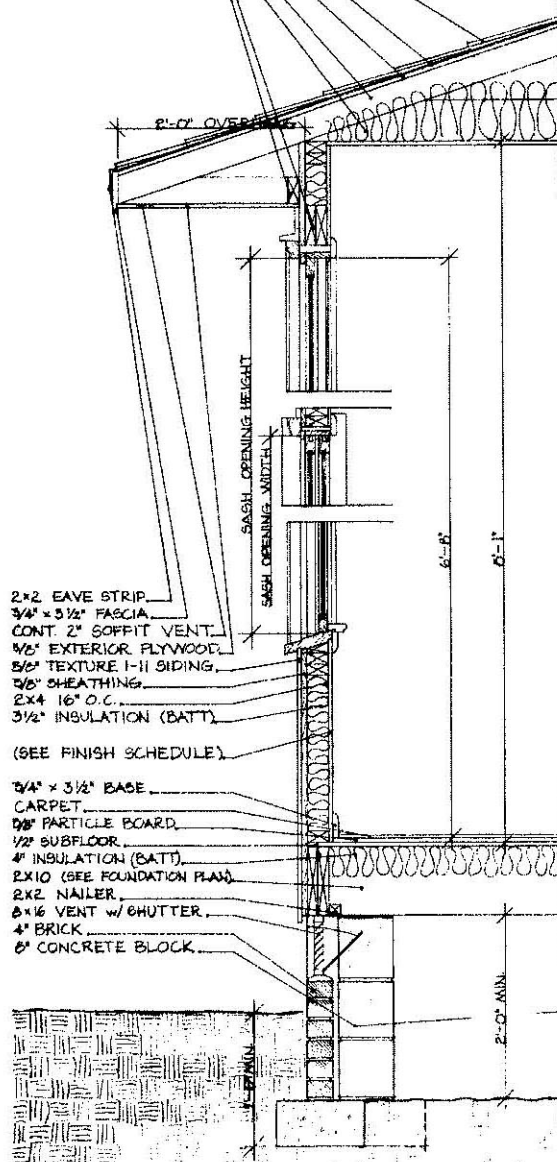


PORCH DETAIL SCALE: 1/2" = 1'-0"

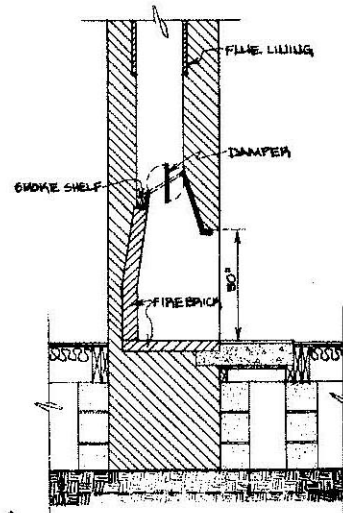

FIREPLACE SECTION SCALE: 1/2" = 1'-0"

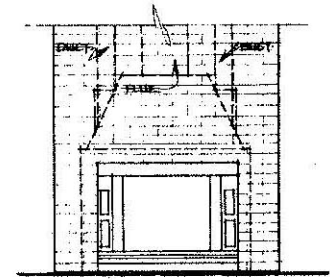


ELEVATION

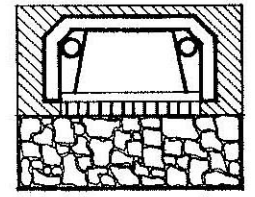

PLAN SCALE: 1/2" = 1'-0"

OPTIONAL HEATER

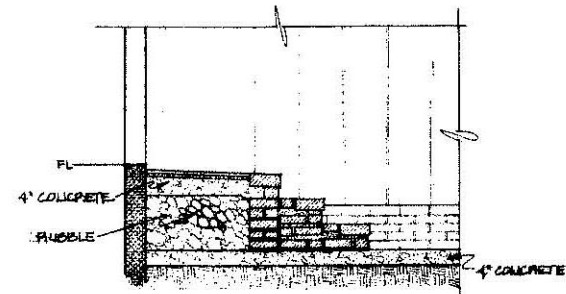


STEPS DETAIL SCALE: 1/2" = 1'-0"



TYPICAL WALL SECTION SCALE: 1" = 1'-0"

PIER DETAIL SCALE: 1" = 1'-0"


COOPERATIVE EXTENSION WORK IN AGRICULTURE AND HOME ECONOMICS STATE OF SOUTH CAROLINA CLEMSON UNIVERSITY		
ENERGY EFFICIENT HOUSE		
SC '80	EX. 8014	SHEET 5 OF 7

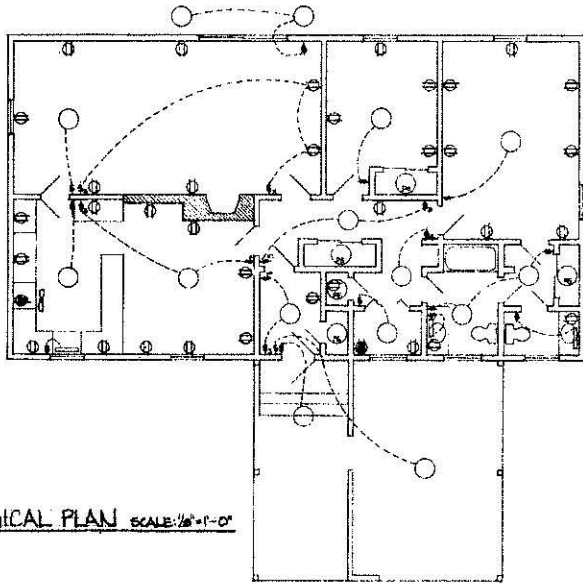

A ELECTRICAL PLAN SCALE: 1/8"=1'-0"

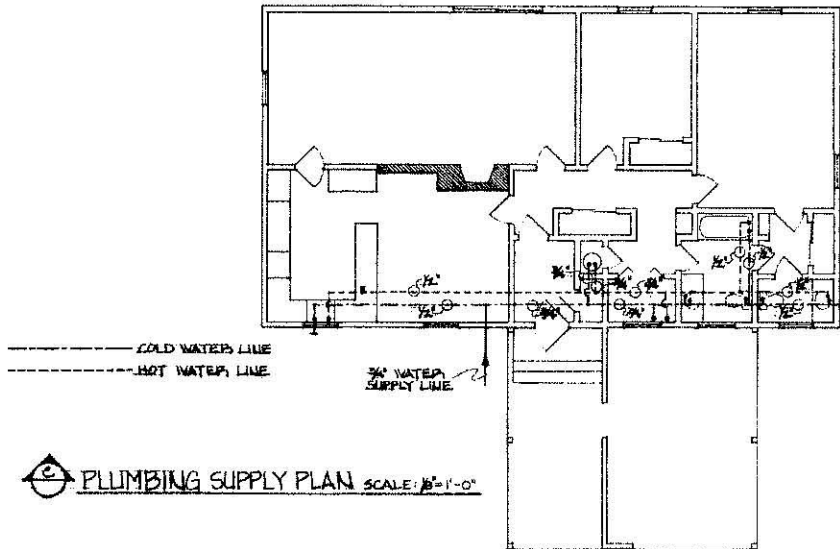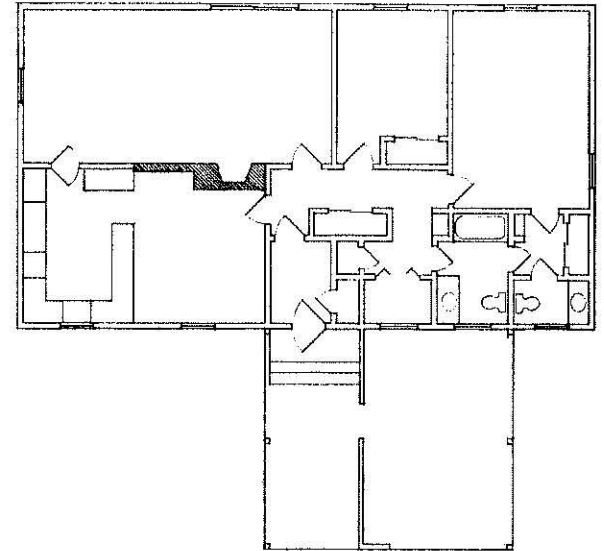

C PLUMBING SUPPLY PLAN SCALE: 1/8"=1'-0"

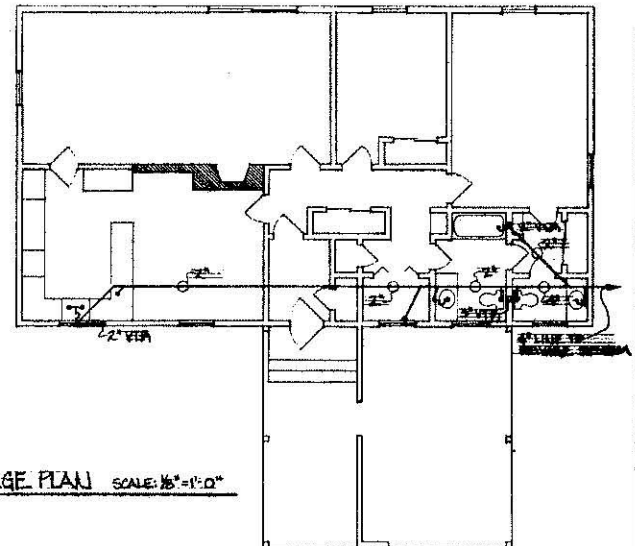

D PLUMBING DRAINAGE PLAN SCALE: 1/8"=1'-0"

COOPERATIVE EXTENSION WORK IN
 AGRICULTURE AND HOME ECONOMICS
 STATE OF SOUTH CAROLINA
 CLEMSON UNIVERSITY

UNIVERSITY OF ARKANSAS

ENERGY-EFFICIENT HOUSE

56 80 EX. 8044 SHEET 7 OF 7