



ELECTRICAL WIRING DIAGRAM

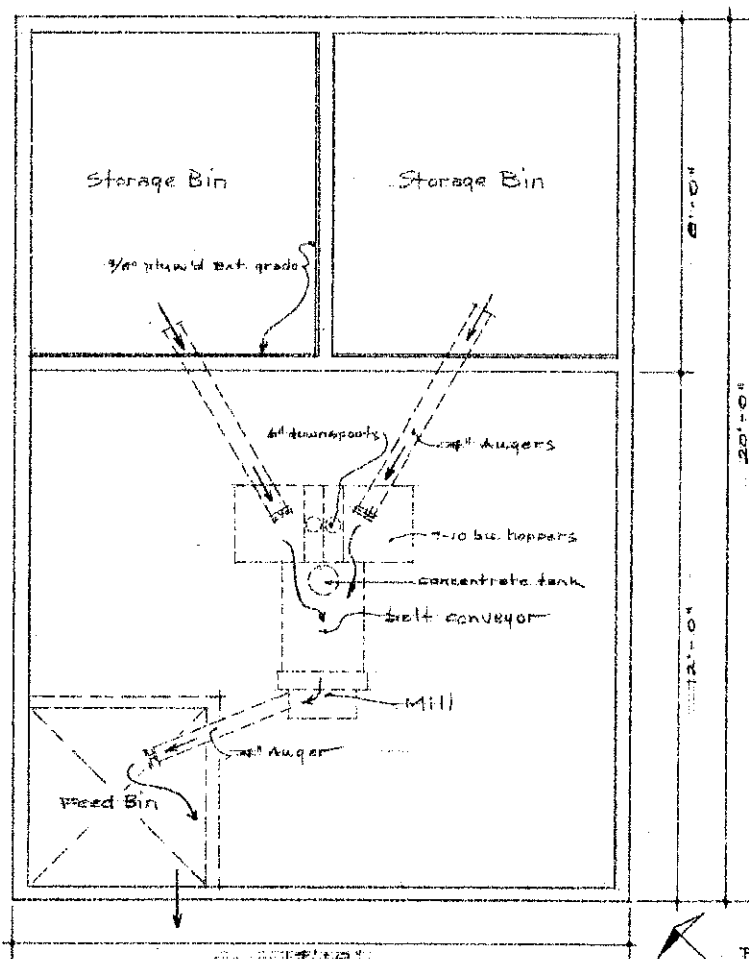

FLOOR PLAN
SCALE: 1/4" = 1'-0"

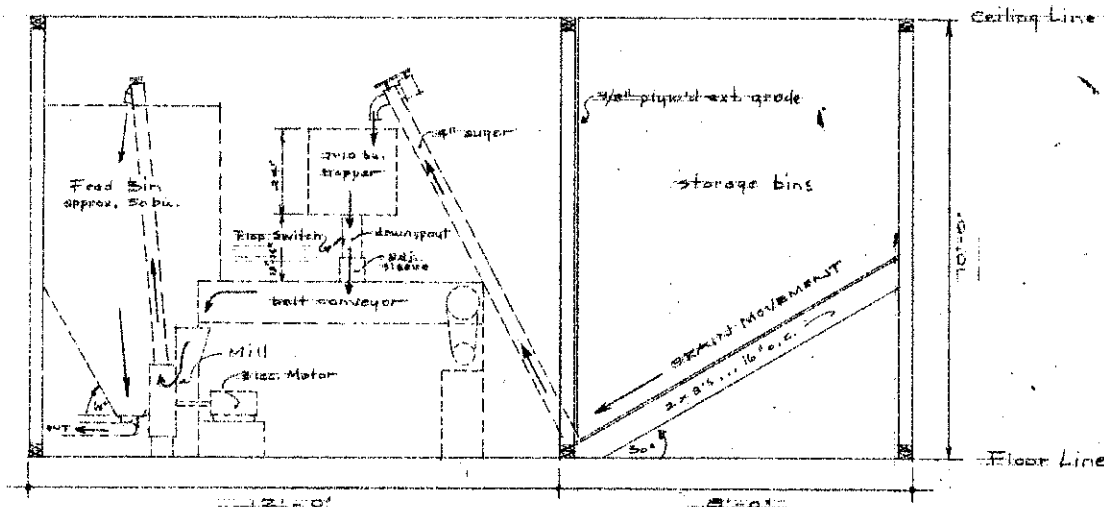

CROSS SECTION VIEW
SCALE: 1/4" = 1'-0"

FEED PROCESSING LAYOUT			
Prepared For	SCALE	DRAWN BY	REVISED
Joe Link Farm		E. G. Cole	
Prepared By	NDSU Extension Agr. Engr. Dept.		
DATE	APPROVED BY	DRAWING NUMBER	
Oct. 63	N.D. 753-1-5	sheet 1 of 1	