



SCHMATIC PROFILE

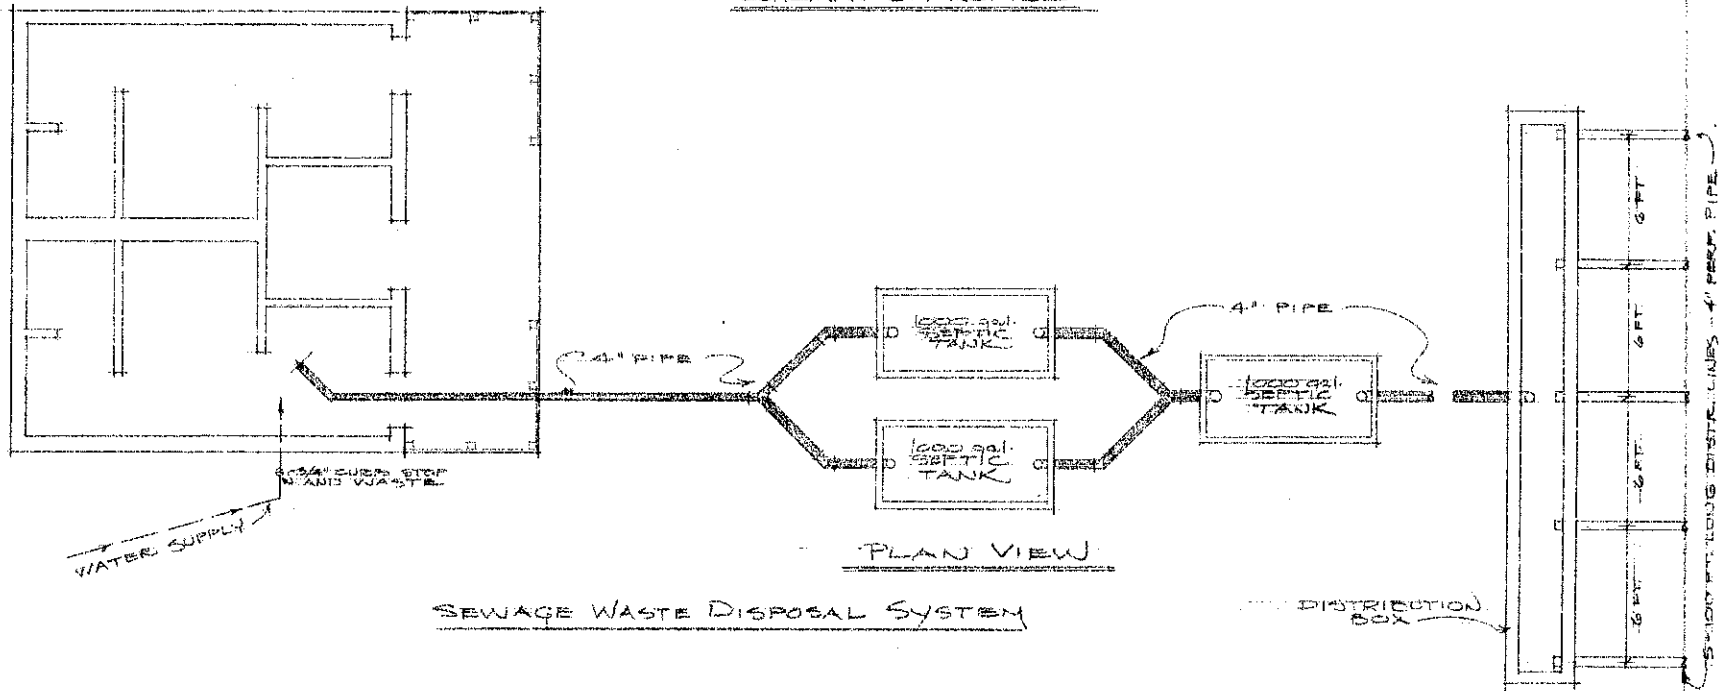


PLAN VIEW

SEWAGE WASTE DISPOSAL SYSTEM

COMFORT STATION FOR PARK			
PREPARED FOR LINTON PARK BOARD	SCALE	DRAWN BY P. G. G. T. O.	
PREPARED BY NDSU EXTENSION AGR. ENG. DEPT.		REVISED	
DATE MAY, '13	APPROVED BY N.D. 766-4-1	DRAWING NUMBER SHT. 1 OF 5	

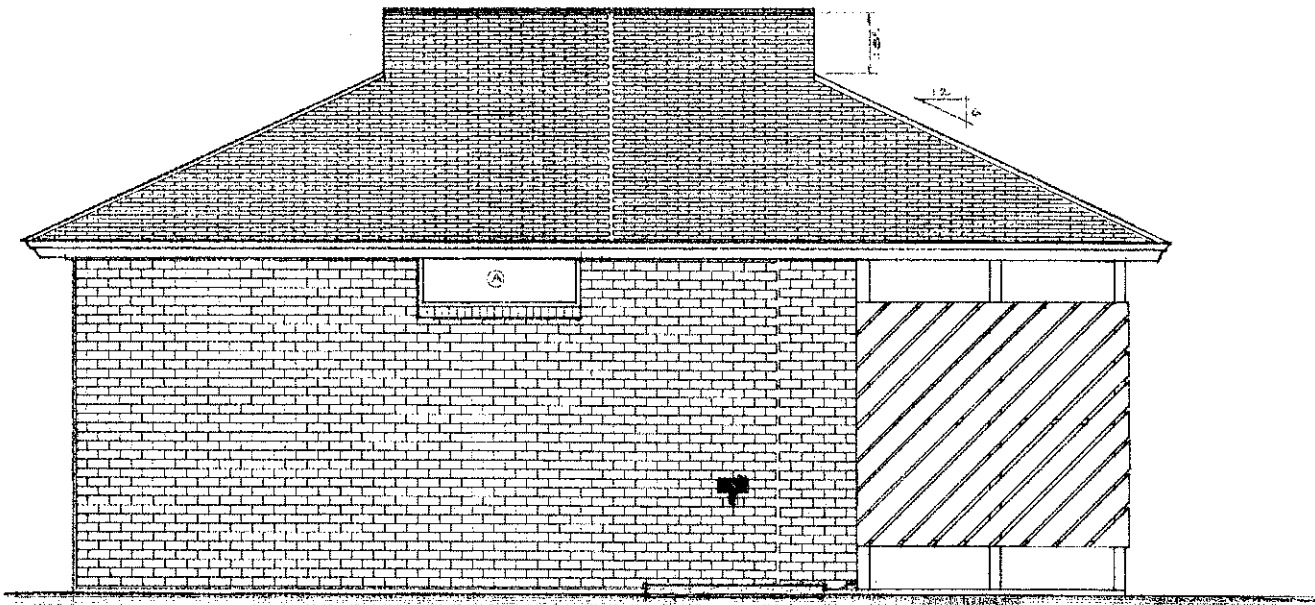

SIDE VIEW

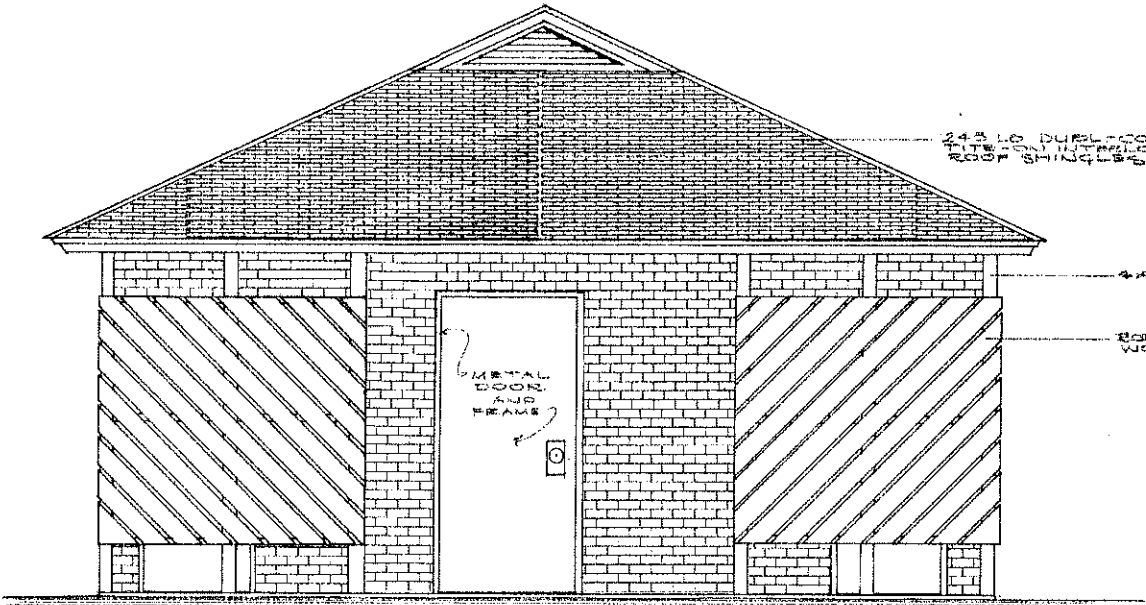

FRONT VIEW


24" x 10" DUELT-COVERAGE
TILE (ON INTERLOCKING ASPHALT
ROOF SHINGLES)

4x4 WOOD POST


BELGH-SAWN OR REDWOOD
WOOD PARTIAL SCREEN

METAL
DOOR
AND
FRAME


COMFORT STATION FOR PARK			
PREPARED BY LINTON PARK BOARD	SCALE 1/2" = 1'-0"	DRAWN BY E. COLLETTE	
REVISIONS BY NDSU EXTENSION AGR. ENGR. DEPT.			
DATE MAY '73	APPROVED BY N.D. 764-4-1	DRAWING NUMBER SHT. 2 OF 5	

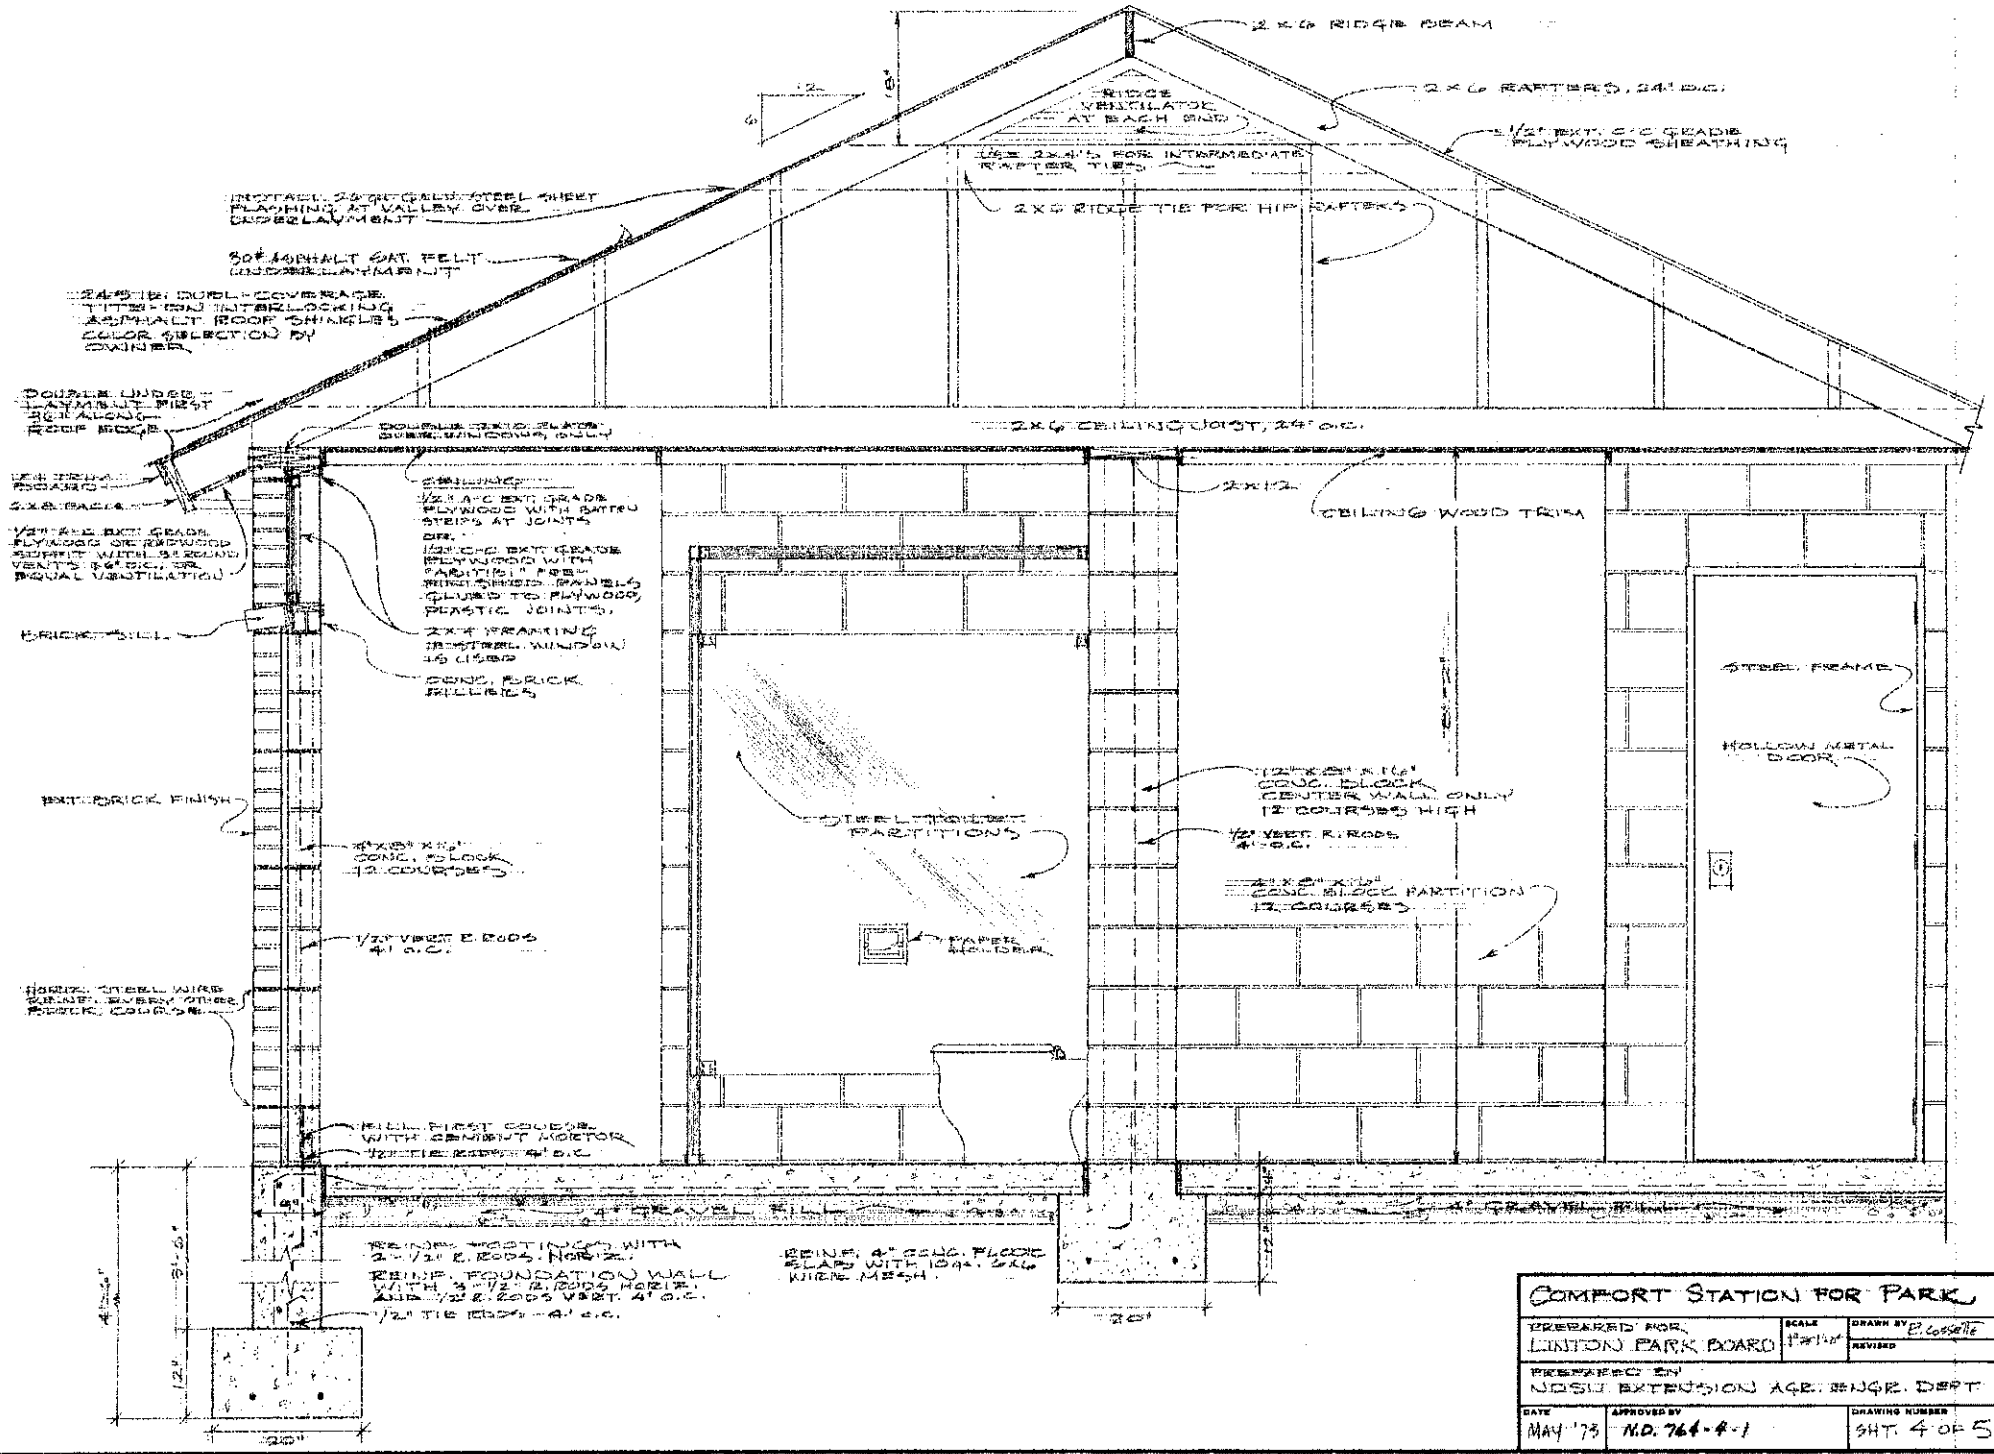

COMFORT STATION FOR PARK			
PREPARED FOR LINTON PARK BOARD	SCALE 1/4" = 1'-0"	DRAWN BY E. Casselle	
PREPARED BY NDSU EXTENSION AGE. ENGR. DEPT.	DATE MAY '73	APPROVED BY NO. 764-4-1	REVISION
DRAWING NUMBER SHT. 4 OF 5			

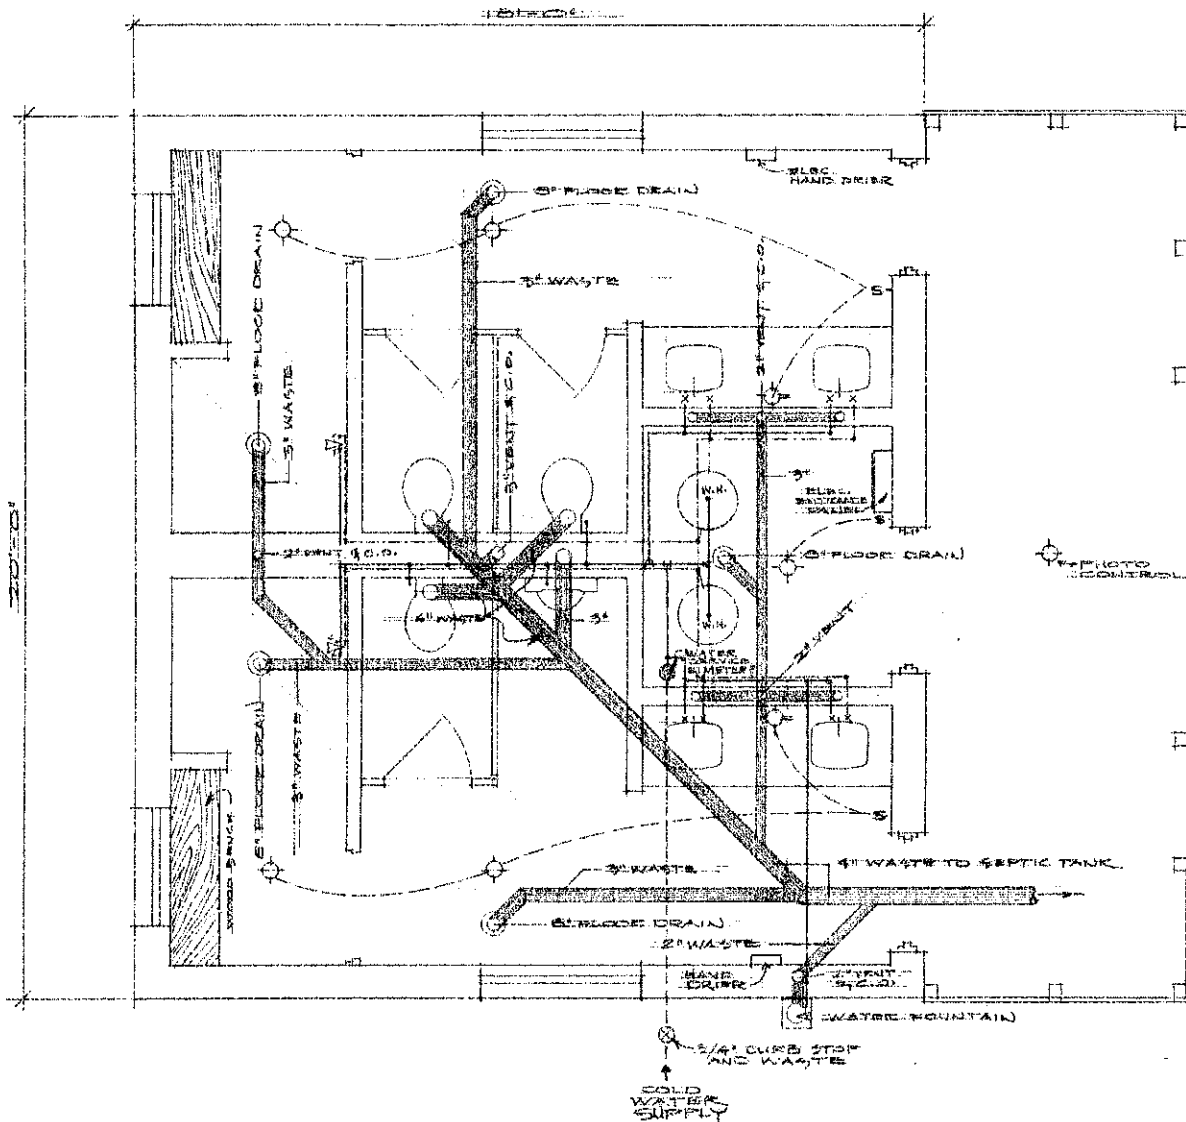

SEWER, WATER, AND ELECTRICAL PLAN
 SCALE: 1/2" = 1'-0"

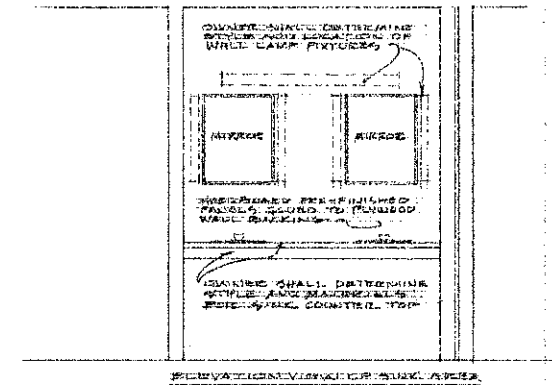

ELECTRICAL
 ALL ELECTRICAL WORK SHALL CONFORM TO NATIONAL, STATE, AND LOCAL CODES. OWNER SHALL SELECT FIXTURES AND DETERMINE STYLE, COLOR, AND QUALITY. WALL FIXTURES AND SINKS SHALL HAVE GUTTERS.
 TWO ELECTRIC HAND DRIERS SHALL BE INSTALLED AS DESIGNATED ON DRAWINGS. SIZE OF ENTRANCE PANEL SHALL BE DETERMINED BY OWNER.

SEWER AND WATER
 ALL PIPING UNDER SLAB SHALL BE CAST IRON SOIL PIPES, GRADED 1/8" / FOOT. WASTE AND VENT PIPING SHALL BE PLASTIC. ALL WORKMANSHIP SHALL CONFORM TO STATE AND LOCAL PLUMBING CODES, THIS INCLUDES THE USE OF REQUIRED MATERIALS AND FITTINGS AS WELL AS CORRECT METHODS OF INSTALLATION. PIPES SHALL BE OF SIZES SHOWN ON DRAWING.

WATER SUPPLY
 INSTALL HOT AND COLD WATER SYSTEMS WITH TYPE L COPPER PIPING AND SWEAT JOINTS. PIPES SHALL BE OF SIZES SHOWN ON DRAWINGS AND LAID WITH GRADE TO DRAIN SO THAT THE ENTIRE SYSTEM CAN DRAIN WITHOUT REMOVING FIXTURES.

OWNER SHALL SELECT PLUMBING FIXTURES AND DETERMINE STYLE, COLOR, AND QUALITY.

20-20 GAL. ELECTRIC WATER HEATERS WITH 4500/4500 ELEMENTS EACH HEATER. 20" x 24" x 1/2" PLATE GLASS, STEEL BACK, COPPER GEALED HANGERS AND TRIM-FLOOR MOUNT DEVICE. TOILET PARTITIONS SHALL BE OF GALVANIZED CONDENSERIZED STEEL WITH BAKED-ON ENAMEL FINISH. OWNER SHALL DETERMINE COLOR, SIZE, AND QUALITY. ALL ACCESSORIES SHALL BE FURNISHED AS DETERMINED BY OWNER.

COMFORT STATION FOR PARK			
PREPARED FOR LINTON PARK BOARD	SCALE N=1	DRAWN BY E. Casse T.C.	
PREPARED BY NDSU EXTENSION AGR. ENGR. DEPT.	DATE MAY 1973	APPROVED BY N.D. 764-451	REVISIONS REVISED
DRAWING NUMBER		SHEET 5 OF 5	